





REV	DATE	BY	DESCRIPTION
1	01.15.17	CA	POWER AND DATA PLAN
2	02.28.17	CA	INSTALLATION DOCUMENT
3	03.03.17	JPVS	INSTALL DOCUMENT
4	03.06.17	JPVS	INSTALL DOCUMENT
5	03.07.17	JPVS	INSTALL DOCUMENT
6	03.14.17	CA	REVISED OVERALL PLAN
7	03.23.17	JPVS	INSTALL
8			
9			
10			
11			
12			

CLIENT APPROVAL DATE: date

CONTACT:

SHEET TITLE
OVERALL PLAN

SCALE	NTS
DATE	03.23.17
PROJECT NO.	108994
PROJECT MGR.	K. Chan / N. Kormier
ACCT. MGR.	J. PILARSKI
DESIGNER NAME	C. ADRIANTI
PHONE NO.	669-800-2632
SHEET NO.	of 4

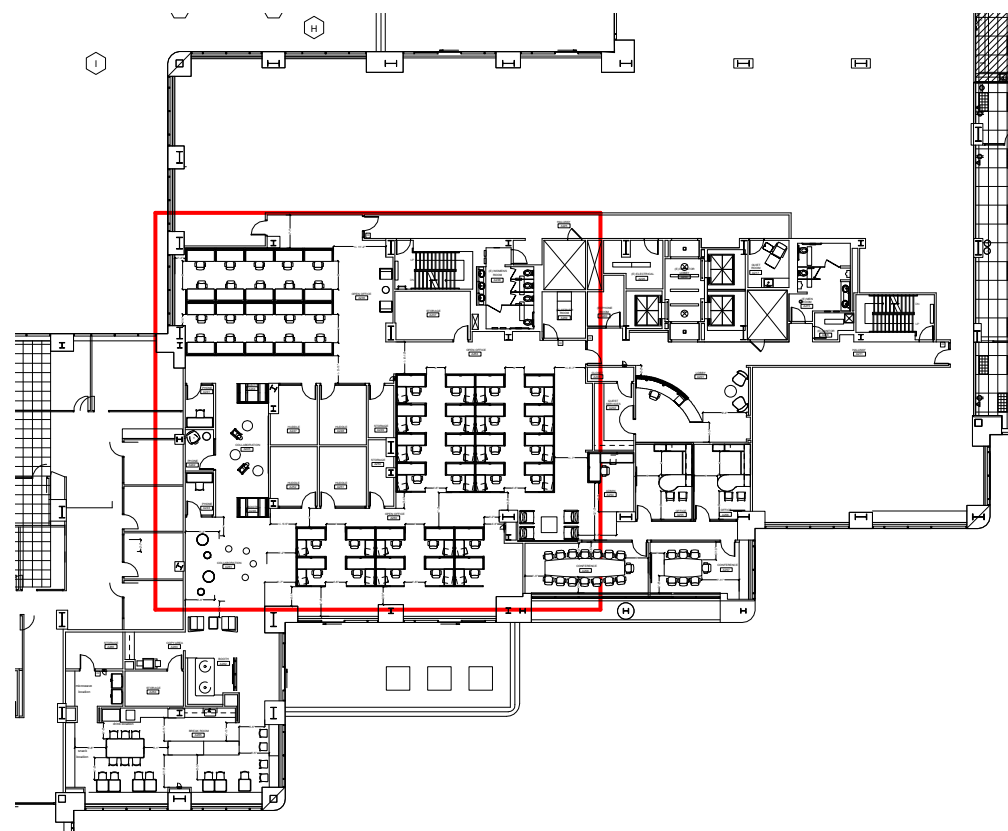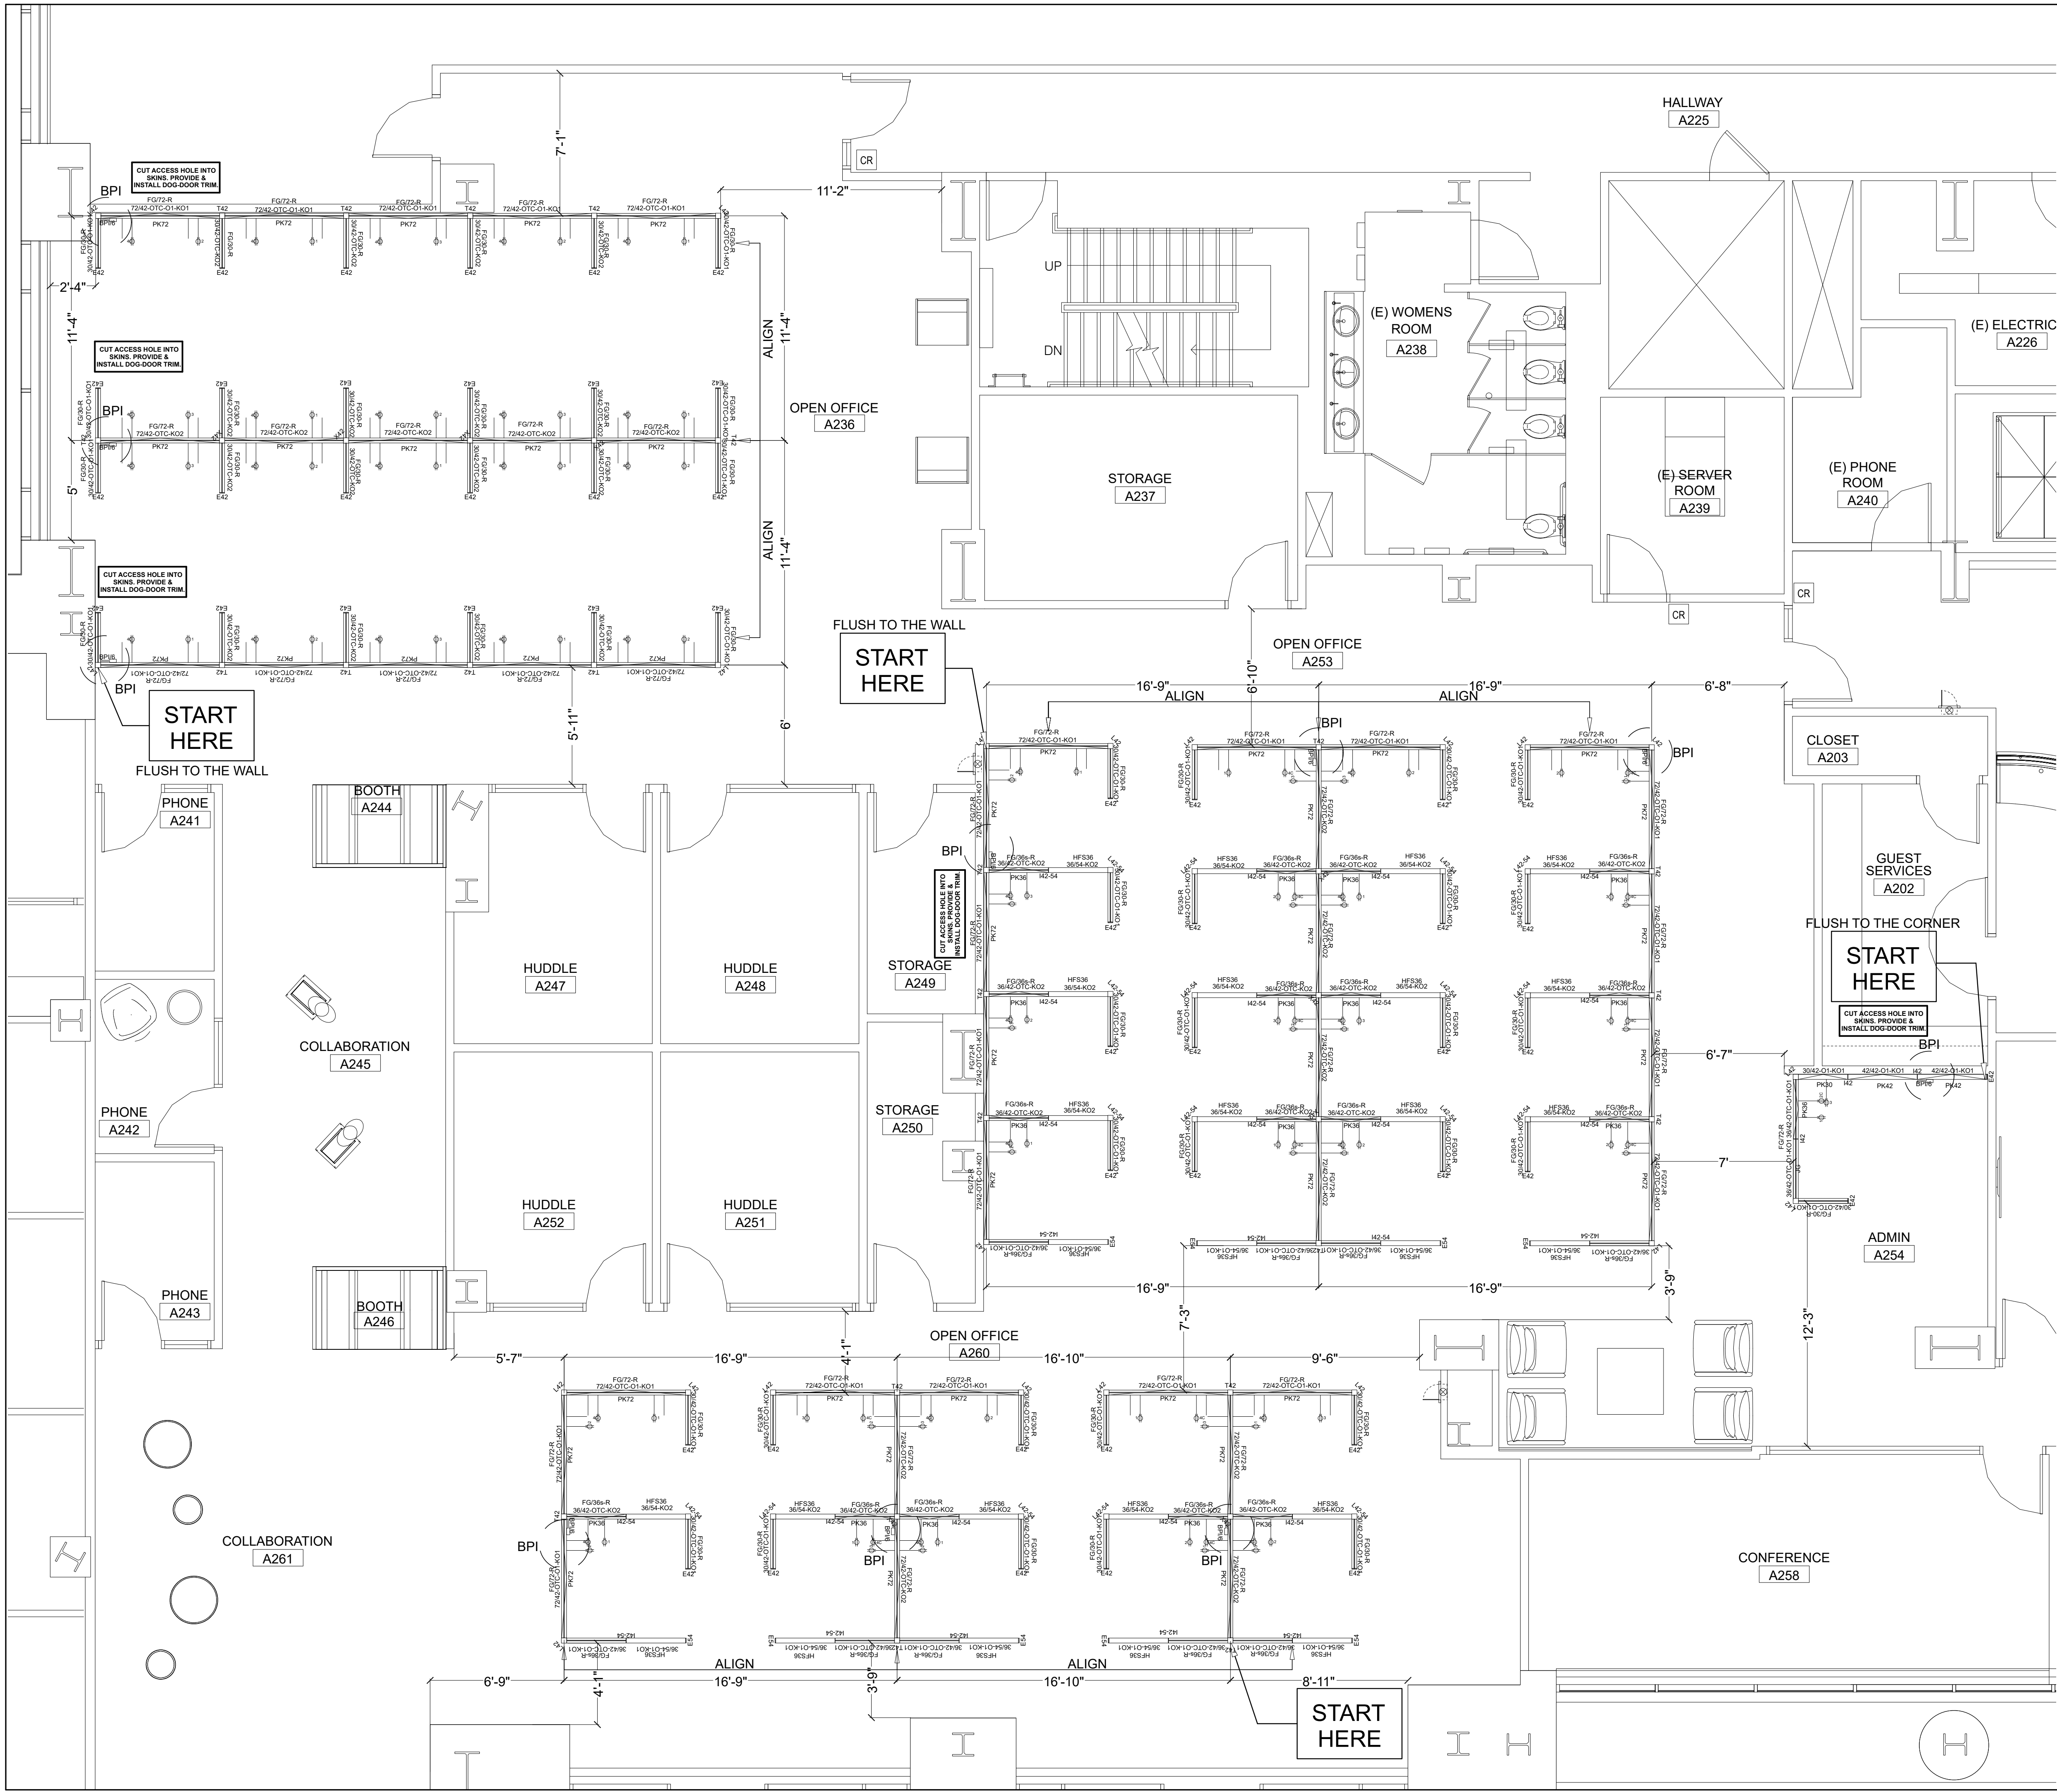

KEY PLAN



ServiceNow Inc
ServiceNow Pleasanton
4305 HACIENDA DR.
PLEASANTON, CA



ONE WORKPLACE HEADQUARTERS
2500 DE LA CRUZ BLVD., SANTA CLARA, CA 95050
TEL 1.888.800.2500 FAX 1.668.800.2501
SAN FRANCISCO
475 BRANNAN ST., STE. 210, SAN FRANCISCO, CA 94107
TEL 1.415.357.2200 FAX 1.415.357.2201
OAKLAND
7229 EDGEWATER DR., OAKLAND, CA 94621
TEL 1.510.729.7800 FAX 1.510.729.7801
WWW.ONEWORKPLACE.COM

- ELECTRICAL NOTES:**
- THIS PLAN IS FOR PLACEMENT RECOMMENDATION ONLY. ONE WORKPLACE IS NEITHER AN ARCHITECT NOR AN ENGINEER. THE BUILDING/GENERAL CONTRACTOR SHALL BE RESPONSIBLE FOR ADHERENCE TO LOCAL BUILDING & ELECTRICAL CODES. ALL NECESSARY WATGAGE AND AMPERAGE SHALL BE DETERMINED BY BUILDING CONTRACTOR BASED ON EQUIPMENT POWER REQUIREMENTS.
 - REVISION AND/OR CHANGES TO THESE PLANS MUST BE SUBMITTED
 - ONE WORKPLACE STUDIO IS TO BE NOTIFIED IMMEDIATELY IF POWER LOCATIONS PROPOSED ON PLAN CANNOT BE ACCOMMODATED.
 - ELECTRICAL CONTRACTOR SHALL VERIFY & MODIFY EXISTING AND PROVIDE & INSTALL NEW CONDUIT, CIRCUITING AND WIRING AS REQUIRED TO PROVIDE APPROPRIATE POWER TO SYSTEM FURNITURE.
 - ELECTRICAL CONTRACTOR SHALL PROVIDE CORRECT AMPERAGE FOR ALL EQUIPMENT.
 - CONNECTION FROM POWER SOURCE TO PANEL BASE IS HANDLED BY MEANS OF EITHER A UL APPROVED BASE POWER/IN ASSEMBLY (1/2" CONDUIT) OR AN INTERNAL PANEL SYSTEM JUNCTION BOX, BOTH PROVIDED BY ONE WORKPLACE. ELECTRICAL CONTRACT TO REFER TO PANEL SYSTEM ELECTRICAL SPECS, PROVIDED BY ONE WORKPLACE PROJECT MANAGER, FOR SPECIFIC FURNITURE SYSTEM REQUIREMENTS.

- GENERAL NOTES:**
- ALL AISLE & CONSTRUCTION DIMENSIONS ARE THE SOLE RESPONSIBILITY OF THE ARCHITECT. ONE WORKPLACE CLAIMS NO RESPONSIBILITY FOR THE ACCURACY OF ANY ARCHITECTURAL ELEMENTS CONTAINED IN THIS PLAN.
 - ALL FURNITURE DIMENSIONS SHOWN ARE HARD DIMENSIONS UNLESS OTHERWISE NOTED.
 - ALL WRITTEN DIMENSIONS TAKE PRECEDENCE OVER SCALED DIMENSIONS.
 - ONE WORKPLACE STUDIO SHOULD BE NOTIFIED IMMEDIATELY REGARDING QUESTIONS PERTAINING TO THESE DRAWINGS.
 - REVISIONS AND/OR CHANGES TO PLANS MUST BE FORMALLY SUBMITTED TO ONE WORKPLACE STUDIO PRIOR TO IMPLEMENTATION OF SAID REVISIONS.
 - ALL FILES SHALL BE GANGED(BOLTED) TOGETHER.

ARCHITECTURE DISCLAIMER

ALL CORRIDOR & CONSTRUCTION DIMENSION ARE THE SOLE RESPONSIBILITY OF THE ARCHITECT. ONE WORKPLACE CLAIMS NO RESPONSIBILITY FOR THE ACCURACY OF ANY ARCHITECTURAL ELEMENTS CONTAINED IN THIS PLAN.

REV	DATE	BY	DESCRIPTION
1	01.15.17	CA	POWER AND DATA PLAN
2	02.28.17	CA	INSTALLATION DOCUMENT
3	03.03.17	PVS	INSTALL DOCUMENT
4	03.06.17	PVS	INSTALL DOCUMENT
5	03.07.17	PVS	INSTALL DOCUMENT
6	02.14.17	CA	REVISED OVERALL PLAN
7	03.22.17	PVS	INSTALL
8			
9			
10			
11			
12			

CLIENT APPROVAL DATE: date

CONTACT:

SHEET TITLE

PANEL & ELEC PLAN

SCALE 1/4" = 1' - 0"

DATE 03.23.17

PROJECT NO. 108994

PROJECT MGR. K. Chan / N. Kottmeyer

ACCT. MGR. J. PLARSKI

DESIGNER NAME C. ADRIANTI

PHONE NO. 669-800-2632

SHEET NO. of 4




REV	DATE	BY	DESCRIPTION
1	01.15.17	CA	POWER AND DATA PLAN
2	02.28.17	CA	INSTALLATION DOCUMENT
3	03.03.17	PVS	INSTALL DOCUMENT
4	03.06.17	PVS	INSTALL DOCUMENT
5	03.07.17	PVS	INSTALL DOCUMENT
6	02.14.17	CA	REVISED OVERALL PLAN
7	02.23.17	PVS	INSTALL
8			
9			
10			
11			
12			

CLIENT APPROVAL DATE: date
CONTACT:

SHEET TITLE
PANEL & ELEV PLAN

SCALE	1/4" = 1' - 0"
DATE	03.23.17
PROJECT NO.	108994
PROJECT MGR.	K. Chan / N. Kottmeyer
ACCT. MGR.	J. PLARSKI
DESIGNER NAME	C. ADRIANI
PHONE NO.	669-800-2632
SHEET NO.	of 4

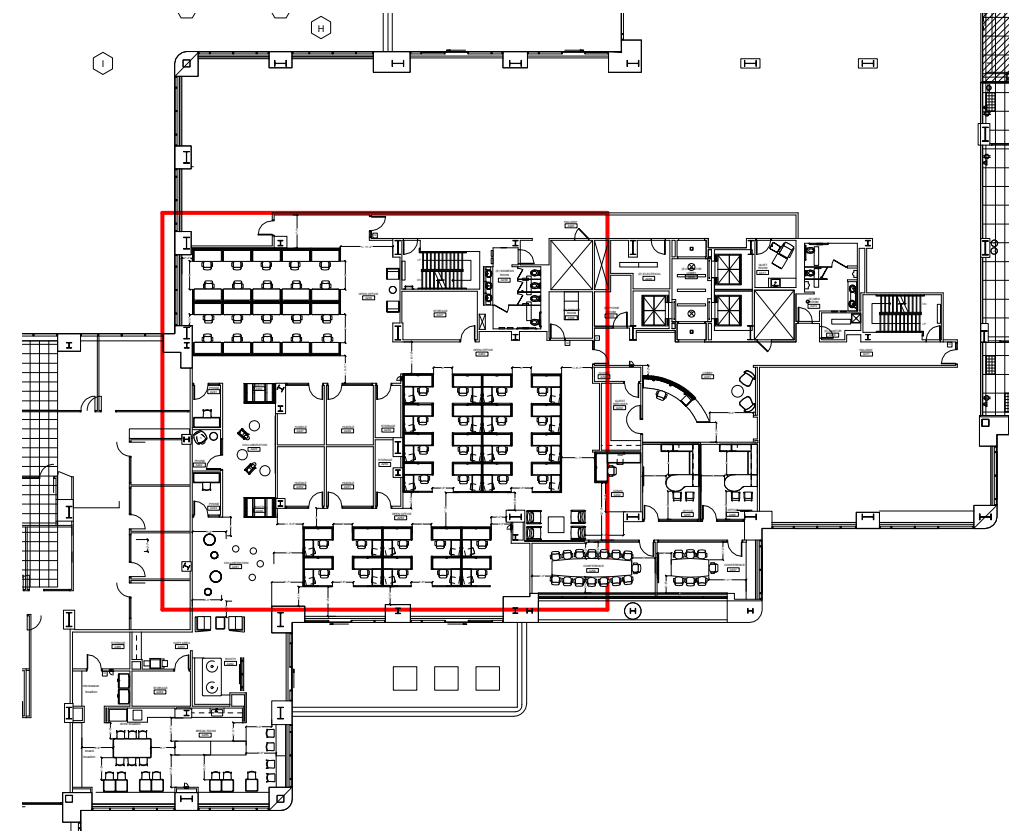

KEY PLAN

Frame Side Types

FS12 MS2 TK08P PS41	FS12 MS2 TK08 PS41	TK08P PS41
A Qty: 35 H:54 W:30	B Qty: 67 H:54 W:30	C Qty: 1 H:42 W:30
TK08 PS41	FS12 MS2 TK08 PS41	FS12 MS2 TK08P PS41
D Qty: 1 H:42 W:30	E Qty: 43 H:54 W:36	F Qty: 9 H:54 W:36
FS12 MS2 TK08 PS41	TK08P PS41	FS12 MS2 TK08P PS41
G Qty: 1 H:54 W:72	H Qty: 17 H:54 W:72	I Qty: 2 H:42 W:42
TK08 PS41	FS12 MS2 TK08 PS41	FS12 MS2 TK08P PS41
J Qty: 2 H:42 W:42	K Qty: 55 H:54 W:72	L Qty: 28 H:54 W:72
TK08P PS41	MS2 TK04 PS41	MS2 TK08 PS41
M Qty: 9 H:54 W:36	N Qty: 28 H:54 W:36	O Qty: 1 H:54 W:36

Commodity Code Legend	Finish Code Legend
FG Frameless Glass Screen	4700 4750 CHAMPAGNE METALLIC
HS Steel	6500 6500 CLEAR GLASS
TK Tackable Acoustic	6530 6530 FROSTED
	PS41 PS41 TWINKLE

ELECTRICAL NOTES:


- THIS PLAN IS FOR PLACEMENT RECOMMENDATION ONLY. ONE WORKPLACE IS NEITHER AN ARCHITECT NOR AN ENGINEER. THE BUILDING/GENERAL CONTRACTOR SHALL BE RESPONSIBLE FOR ADHERENCE TO LOCAL BUILDING & ELECTRICAL CODES. ALL NECESSARY WATGAGE AND AMPERAGE SHALL BE DETERMINED BY BUILDING CONTRACTOR BASED ON EQUIPMENT POWER REQUIREMENTS.
- REVISION AND/OR CHANGES TO THESE PLANS MUST BE SUBMITTED
- ONE WORKPLACE STUDIO IS TO BE NOTIFIED IMMEDIATELY IF POWER LOCATIONS PROPOSED ON PLAN CANNOT BE ACCOMMODATED.
- ELECTRICAL CONTRACTOR SHALL VERIFY & MODIFY EXISTING AND PROVIDE A INSTALL NEW CONDUIT, CIRCUITING AND WIRING AS REQUIRED TO PROVIDE APPROPRIATE POWER TO SYSTEM FURNITURE.
- ELECTRICAL CONTRACTOR SHALL PROVIDE CORRECT AMPERAGE FOR ALL EQUIPMENT.
- CONNECTION FROM POWER SOURCE TO PANEL BASE IS HANDLED BY MEANS OF EITHER A UL APPROVED BASE POWER/AN ASSEMBLY (1/2" CONDUIT) OR AN INTERNAL PANEL SYSTEM JUNCTION BOX. BOTH PROVIDED BY ONE WORKPLACE. ELECTRICAL CONTRACT TO REFER TO PANEL SYSTEM ELECTRICAL SPECS, PROVIDED BY ONE WORKPLACE PROJECT MANAGER, FOR SPECIFIC FURNITURE SYSTEM REQUIREMENTS.



GENERAL NOTES:

- ALL AISLE & CONSTRUCTION DIMENSIONS ARE THE SOLE RESPONSIBILITY OF THE ARCHITECT. ONE WORKPLACE CLAIMS NO RESPONSIBILITY FOR THE ACCURACY OF ANY ARCHITECTURAL ELEMENTS CONTAINED IN THIS PLAN.
- ALL FURNITURE DIMENSIONS SHOWN ARE HARD DIMENSIONS UNLESS OTHERWISE NOTED.
- ALL WRITTEN DIMENSIONS TAKE PRECEDENCE OVER SCALED DIMENSIONS.
- ONE WORKPLACE STUDIO SHOULD BE NOTIFIED IMMEDIATELY REGARDING QUESTIONS PERTAINING TO THESE DRAWINGS.
- REVISIONS AND/OR CHANGES TO PLANS MUST BE FORMALLY SUBMITTED TO ONE WORKPLACE STUDIO PRIOR TO IMPLEMENTATION OF SAID REVISIONS.
- ALL FILES SHALL BE GANGED(BOLTED) TOGETHER.

ARCHITECTURE DISCLAIMER

ALL CORRIDOR & CONSTRUCTION DIMENSION ARE THE SOLE RESPONSIBILITY OF THE ARCHITECT. ONE WORKPLACE CLAIMS NO RESPONSIBILITY FOR THE ACCURACY OF ANY ARCHITECTURAL ELEMENTS CONTAINED IN THIS PLAN.

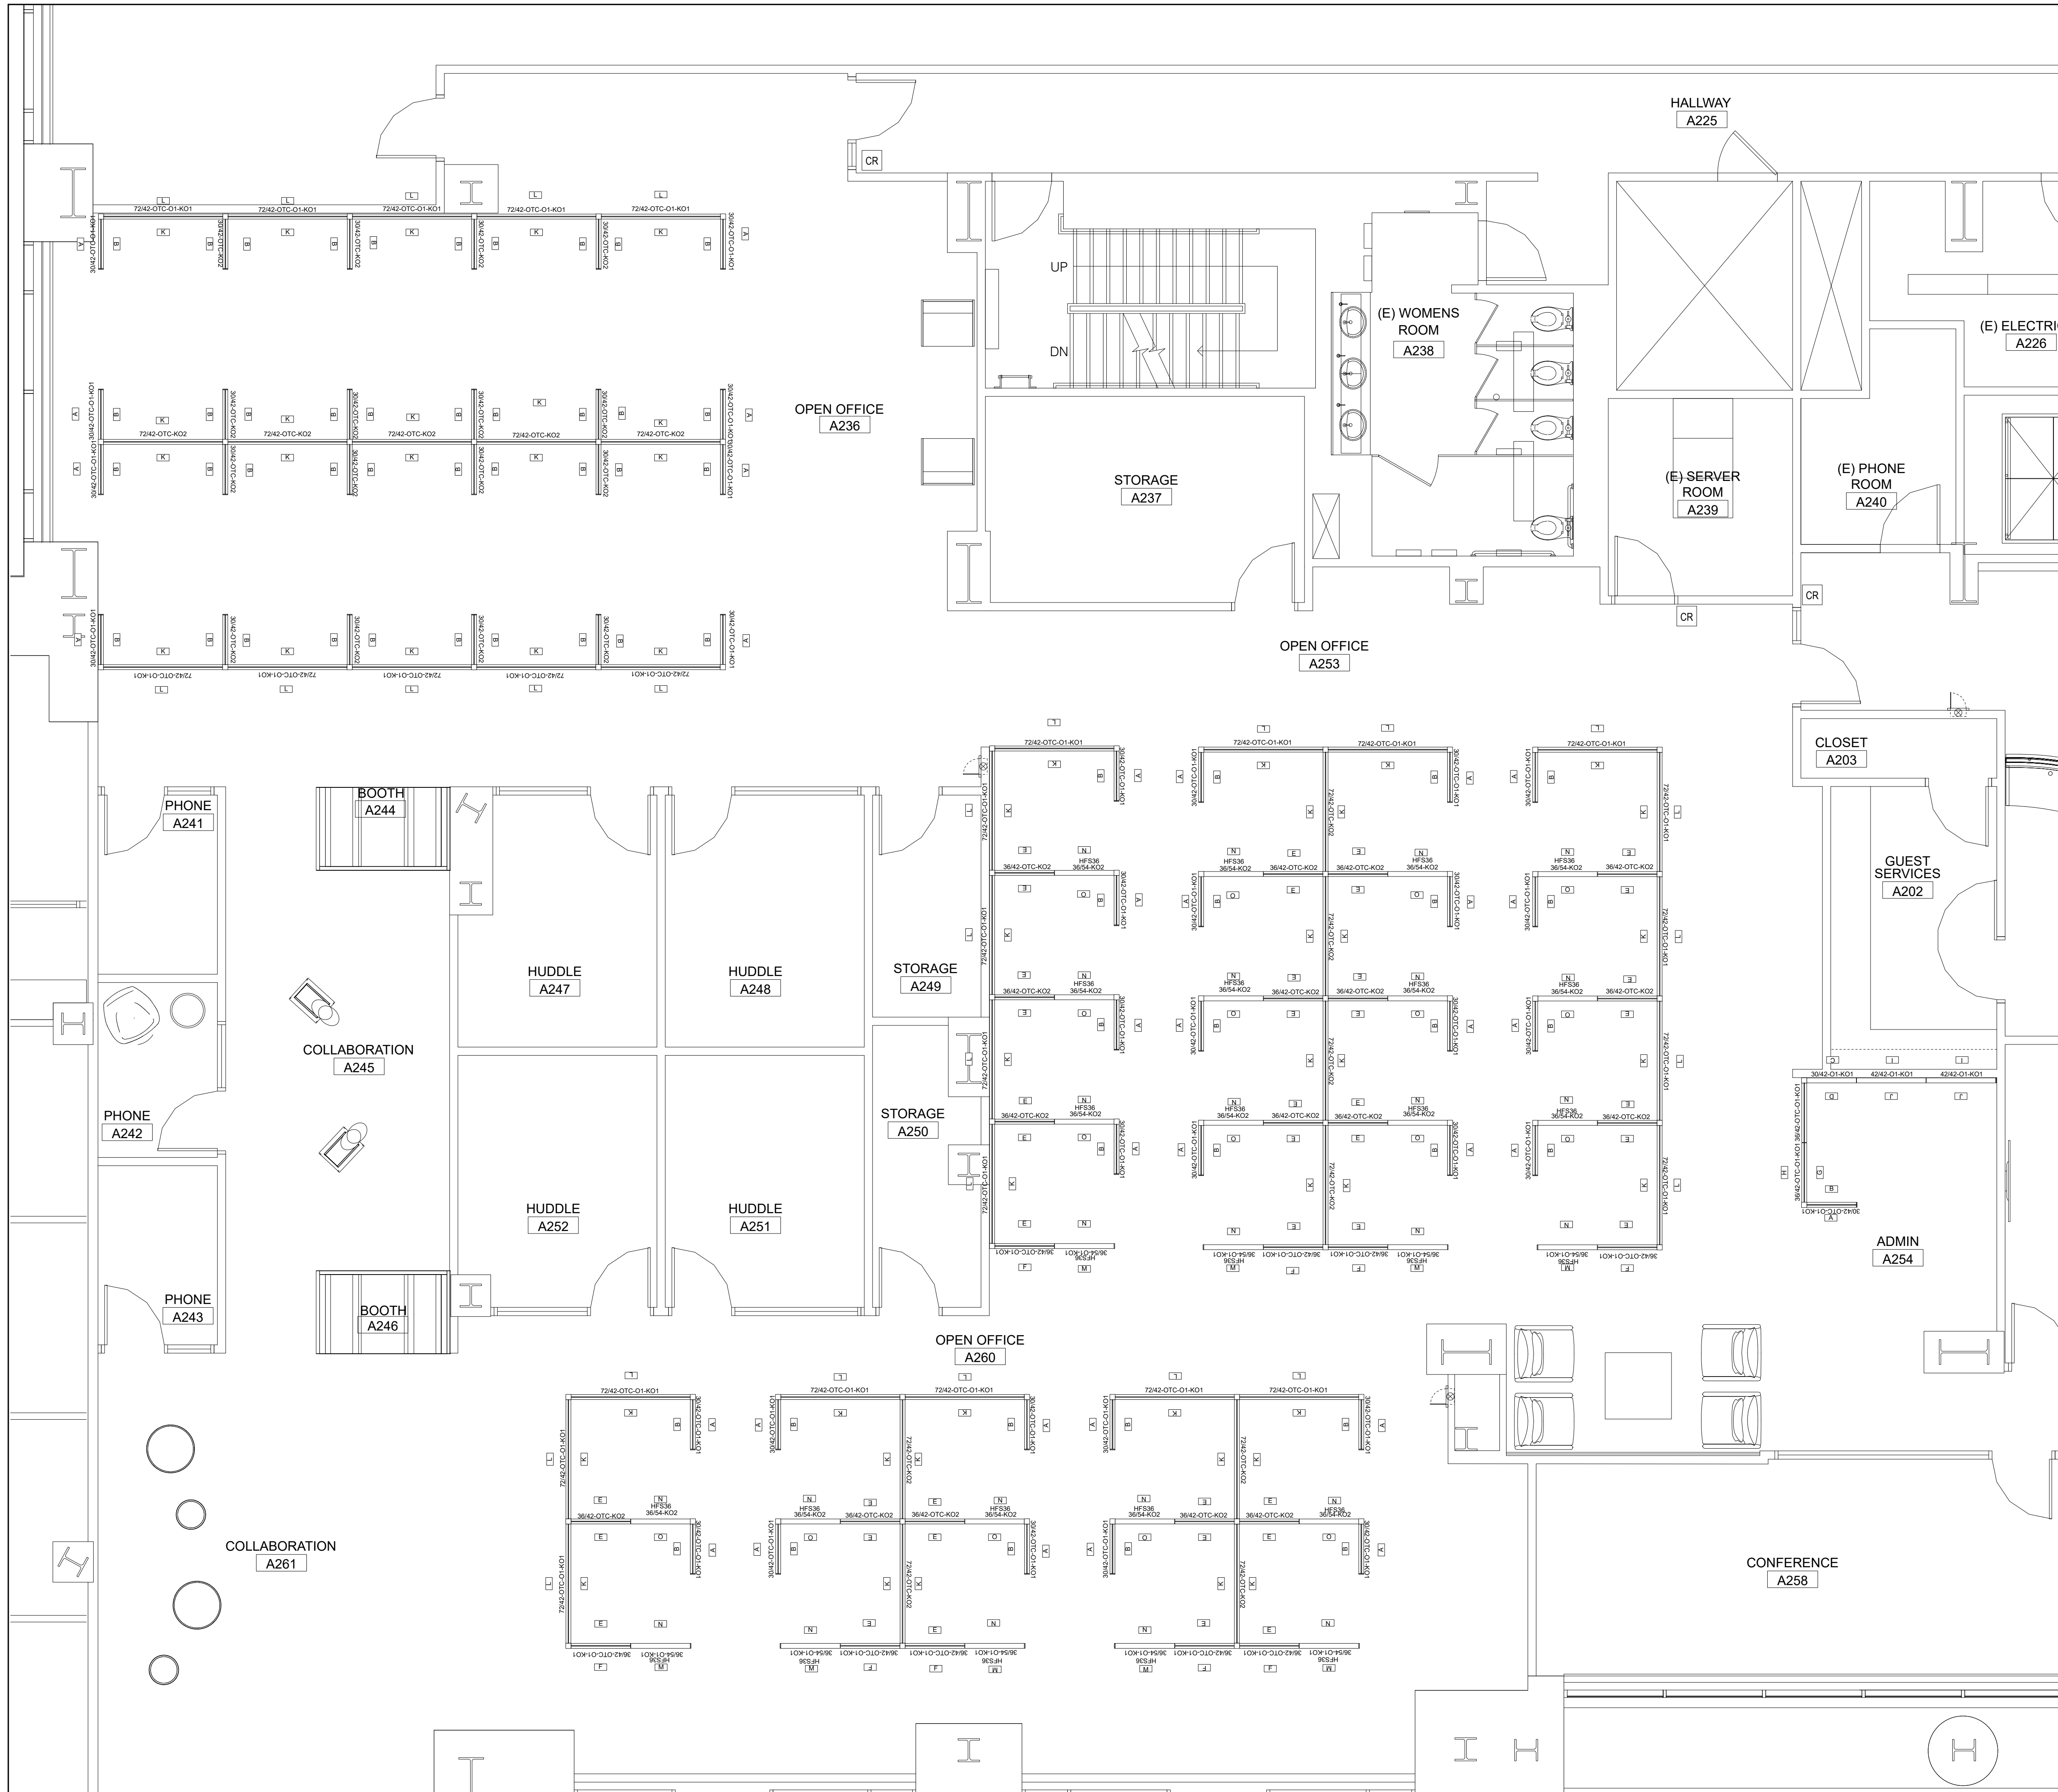

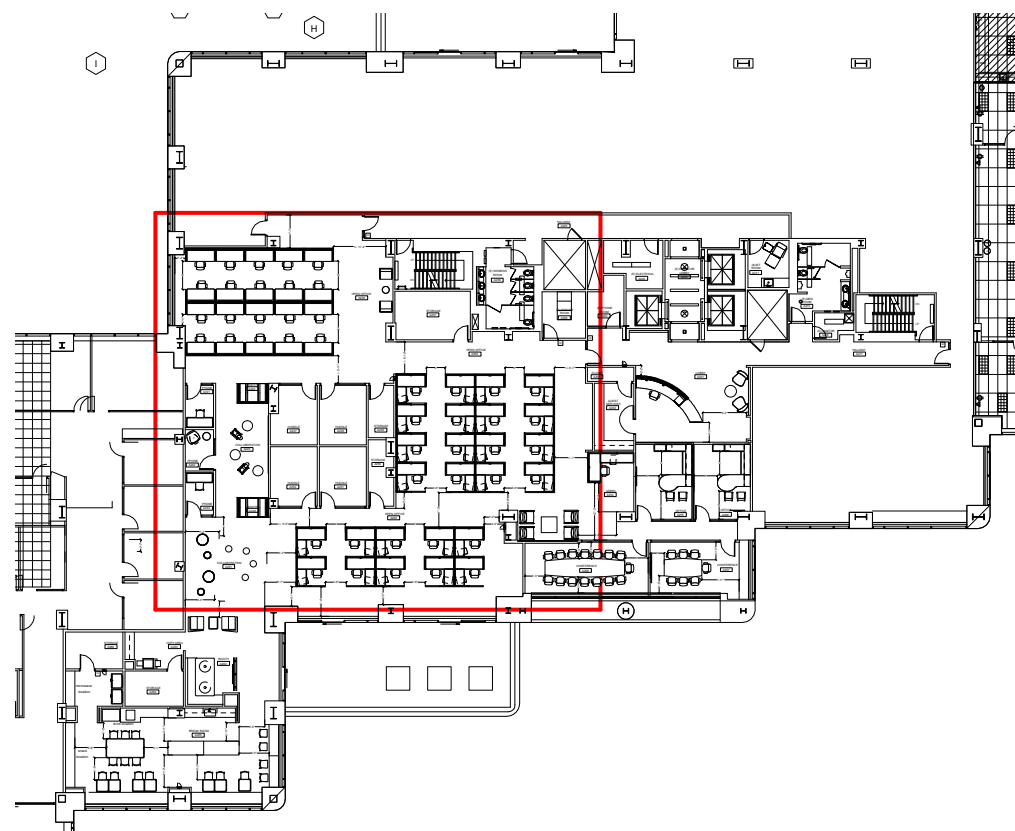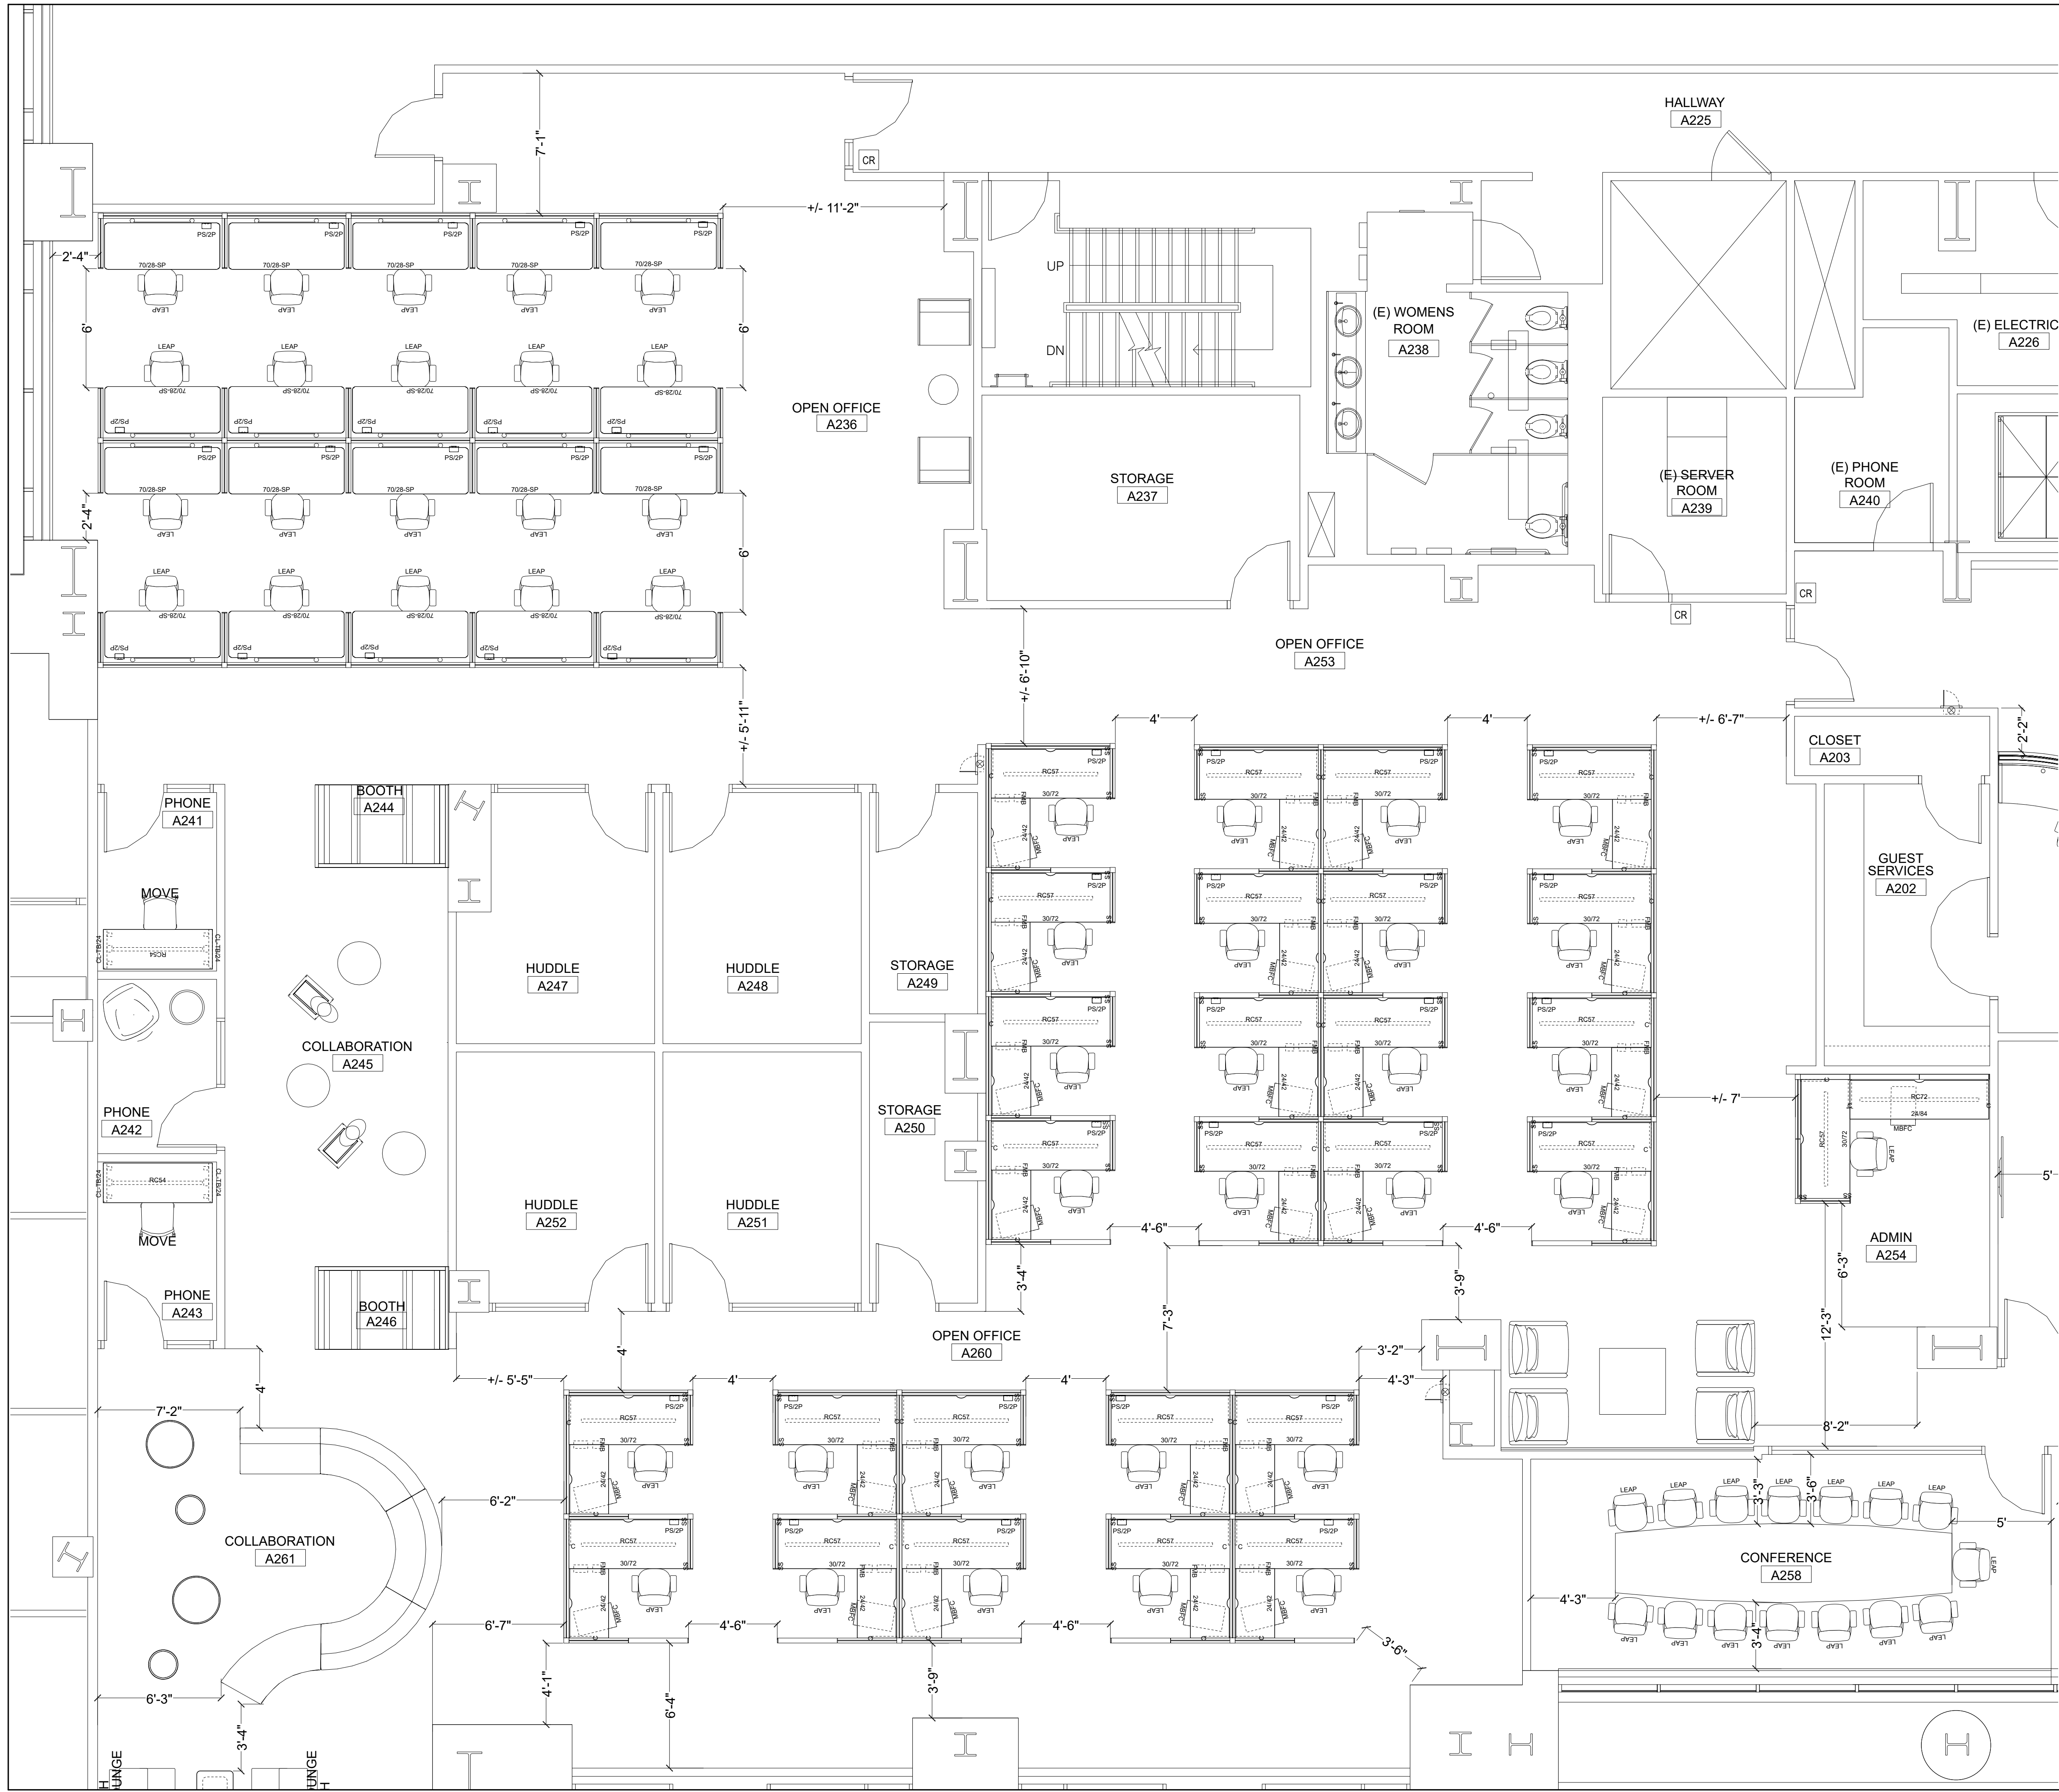

ELECTRICAL NOTES:

- THIS PLAN IS FOR PLACEMENT RECOMMENDATION ONLY. ONE WORKPLACE IS NEITHER AN ARCHITECT NOR AN ENGINEER. THE BUILDING/GENERAL CONTRACTOR SHALL BE RESPONSIBLE FOR ADHERENCE TO LOCAL BUILDING & ELECTRICAL CODES. ALL NECESSARY WATAGE AND AMPERAGE SHALL BE DETERMINED BY BUILDING CONTRACTOR BASED ON EQUIPMENT POWER REQUIREMENTS.
- REVISION AND/OR CHANGES TO THESE PLANS MUST BE SUBMITTED BY MEANS OF EITHER A U.I. APPROVED BASE POWER/AN ASSEMBLY (1/2" CONDUIT) OR AN INTERNAL PANEL SYSTEM JUNCTION BOX, BOTH PROVIDED BY ONE WORKPLACE. ELECTRICAL CONTRACT TO REFER TO PANEL SYSTEM ELECTRICAL SPECS, PROVIDED BY ONE WORKPLACE PROJECT MANAGER, FOR SPECIFIC FURNITURE SYSTEM REQUIREMENTS.
- REVISION AND/OR CHANGES TO THESE PLANS MUST BE SUBMITTED BY MEANS OF EITHER A U.I. APPROVED BASE POWER/AN ASSEMBLY (1/2" CONDUIT) OR AN INTERNAL PANEL SYSTEM JUNCTION BOX, BOTH PROVIDED BY ONE WORKPLACE. ELECTRICAL CONTRACT TO REFER TO PANEL SYSTEM ELECTRICAL SPECS, PROVIDED BY ONE WORKPLACE PROJECT MANAGER, FOR SPECIFIC FURNITURE SYSTEM REQUIREMENTS.
- ELECTRICAL CONTRACTOR SHALL VERIFY & MODIFY EXISTING AND PROVIDE A INSTALL NEW CONDUIT, CIRCUITING AND WIRING AS REQUIRED TO PROVIDE APPROPRIATE POWER TO SYSTEM FURNITURE.
- ELECTRICAL CONTRACTOR SHALL PROVIDE CORRECT AMPERAGE FOR ALL EQUIPMENT.
- CONNECTION FROM POWER SOURCE TO PANEL BASE IS HANDLED BY MEANS OF EITHER A U.I. APPROVED BASE POWER/AN ASSEMBLY (1/2" CONDUIT) OR AN INTERNAL PANEL SYSTEM JUNCTION BOX, BOTH PROVIDED BY ONE WORKPLACE. ELECTRICAL CONTRACT TO REFER TO PANEL SYSTEM ELECTRICAL SPECS, PROVIDED BY ONE WORKPLACE PROJECT MANAGER, FOR SPECIFIC FURNITURE SYSTEM REQUIREMENTS.

GENERAL NOTES:

- ALL ASILE & CONSTRUCTION DIMENSIONS ARE THE SOLE RESPONSIBILITY OF THE ARCHITECT. ONE WORKPLACE CLAIMS NO RESPONSIBILITY FOR THE ACCURACY OF ANY ARCHITECTURAL ELEMENTS CONTAINED IN THIS PLAN.
- ALL FURNITURE DIMENSIONS SHOWN ARE HARD DIMENSIONS UNLESS OTHERWISE NOTED.
- ALL WRITTEN DIMENSIONS TAKE PRECEDENCE OVER SCALED DIMENSIONS.
- ONE WORKPLACE STUDIO SHOULD BE NOTIFIED IMMEDIATELY REGARDING QUESTIONS PERTAINING TO THESE DRAWINGS.
- REVISIONS AND/OR CHANGES TO PLANS MUST BE FORMALLY SUBMITTED TO ONE WORKPLACE STUDIO PRIOR TO IMPLEMENTATION OF SAID REVISIONS.
- ALL FILES SHALL BE GANGED(BOLTED) TOGETHER.

ARCHITECTURE DISCLAIMER

ALL CORRIDOR & CONSTRUCTION DIMENSION ARE THE SOLE RESPONSIBILITY OF THE ARCHITECT. ONE WORKPLACE CLAIMS NO RESPONSIBILITY FOR THE ACCURACY OF ANY ARCHITECTURAL ELEMENTS CONTAINED IN THIS PLAN.



ServiceNow Inc
ServiceNow Pleasanton
4305 HACIENDA DR.
PLEASANTON, CA



ONE WORKPLACE HEADQUARTERS
2500 DE LA CRUZ BLVD., SANTA CLARA, CA 95050
TEL 1.888.800.2500 FAX 1.668.800.2501
SAN FRANCISCO
475 BRANNAN ST., STE. 210, SAN FRANCISCO, CA 94107
TEL 1.415.357.2200 FAX 1.415.357.2201
OAKLAND
7225 EDGEMONT DR., OAKLAND, CA 94621
TEL 1.510.729.7800 FAX 1.510.729.7801
WWW.ONWORKPLACE.COM

REV	DATE	BY	DESCRIPTION
1	01.15.17	CA	POWER AND DATA PLAN
2	02.28.17	CA	INSTALLATION DOCUMENT
3	03.03.17	PSIS	INSTALL DOCUMENT
4	03.06.17	PSIS	INSTALL DOCUMENT
5	03.07.17	PSIS	INSTALL DOCUMENT
6	03.14.17	CA	REVISED OVERALL PLAN
7	03.23.17	PSIS	INSTALL
8			
9			
10			
11			
12			

CLIENT APPROVAL DATE: date
CONTACT:

SHEET TITLE
COMPONENT PLAN

SCALE	1/4" = 1' - 0"
DATE	03.23.17
PROJECT NO.	108994
PROJECT MGR.	K. Chan / K. Kottmeyer
ACCT. MGR.	J. PLARSKI
DESIGNER NAME	C. ADRIANTI
PHONE NO.	669-800-2632
SHEET NO.	of 4